


EXISTING FIRST FLOOR PLAN (BLDG. TYPE - B)
SCALE : 1:100

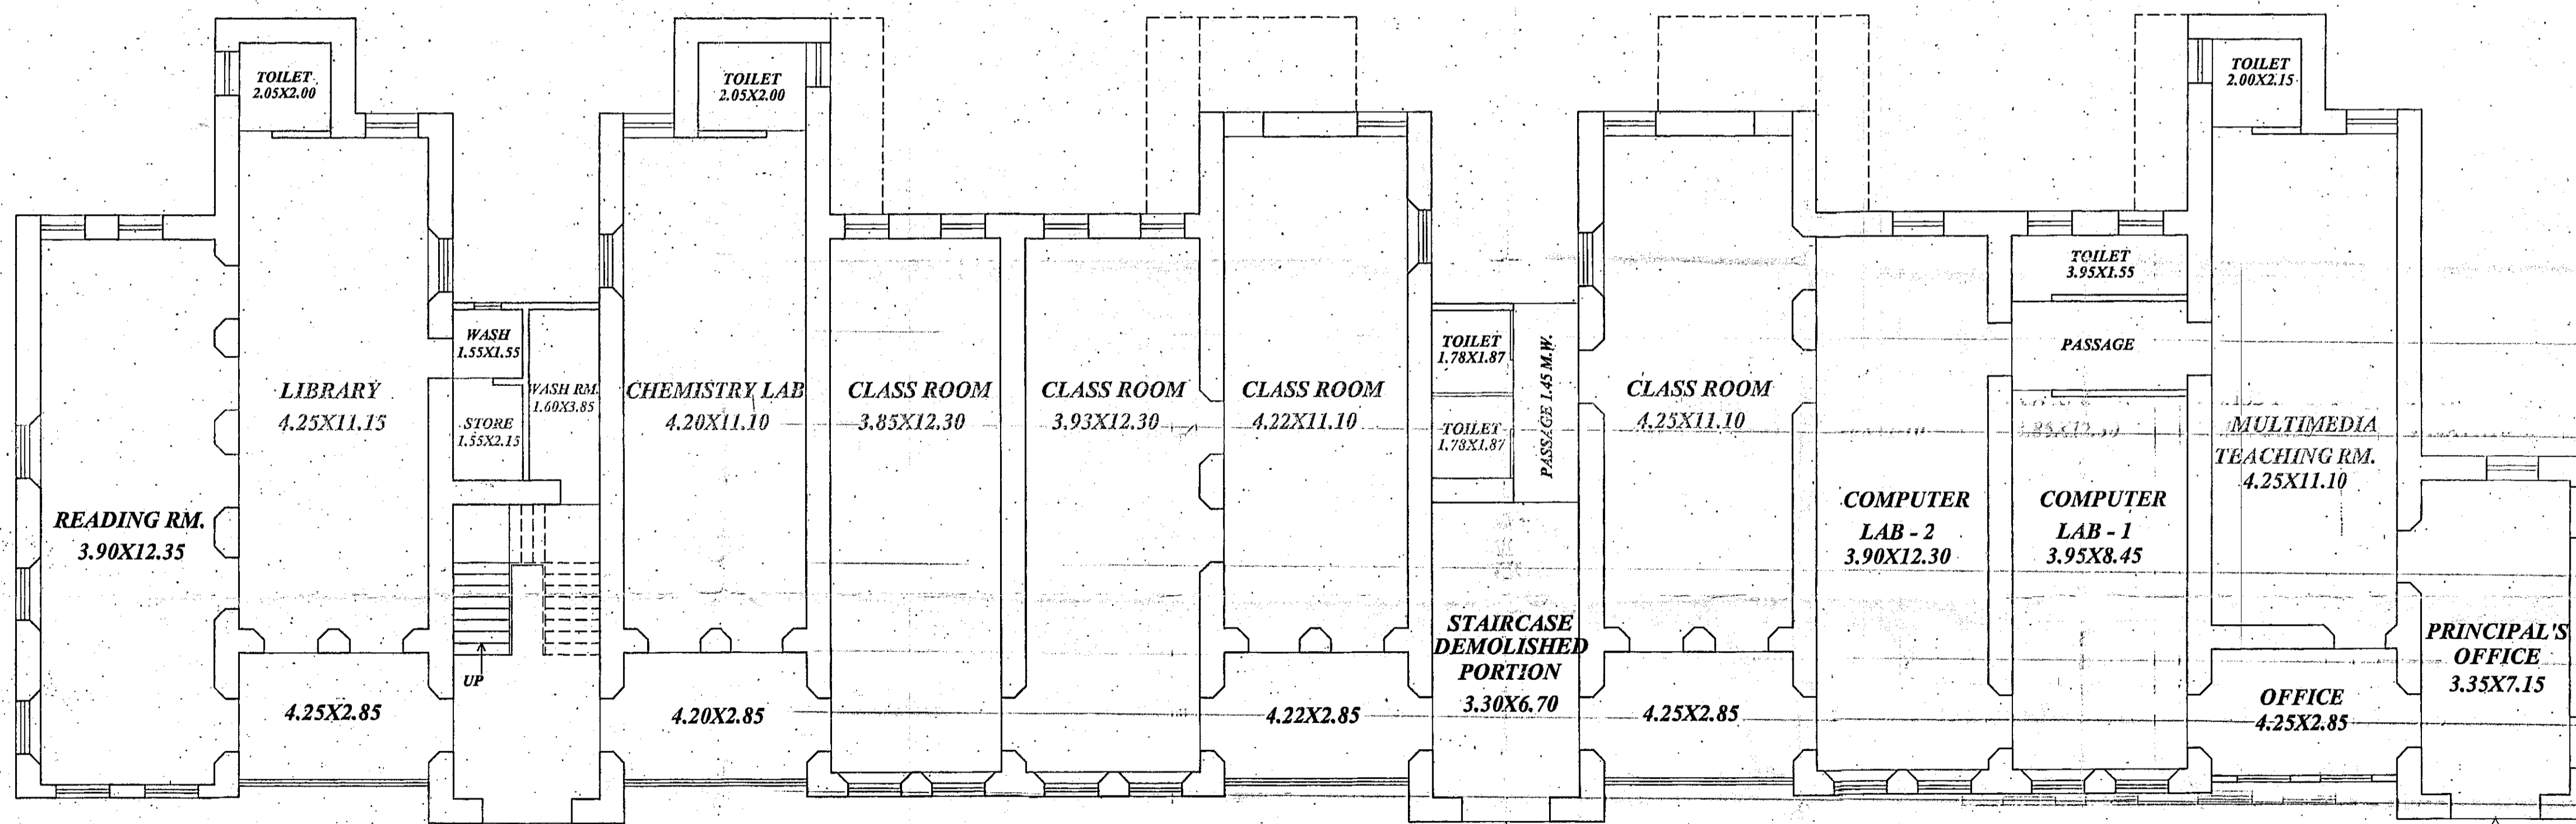

EXISTING GROUND FLOOR PLAN (BLDG. TYPE - B)
SCALE : 1:100

DESCRIPTION OF PROPOSAL & PROPERTY

CENTRAL RAILWAY SCHOOL & JUNIOR COLLEGE, KALYAN.

DESCRIPTION OF PROPOSAL & PRO.

NORTH

ARCHITECTS & CONSULTANTS

De-con Consultants
 ARCHITECTS, INTERIOR DESIGNERS,
 REGD. VALUERS & PROJECT CONSULTANTS
 S-1, RAJASHREE TOWER, RAMBAUG, LANE No. 6,
 KALYAN(WEST)-421 304. Tel. 5817899.